



C:\Users\joshm\Documents\4360 WREC CD REV01_Architectural.dwg
1/14/2020 12:29:24 PM

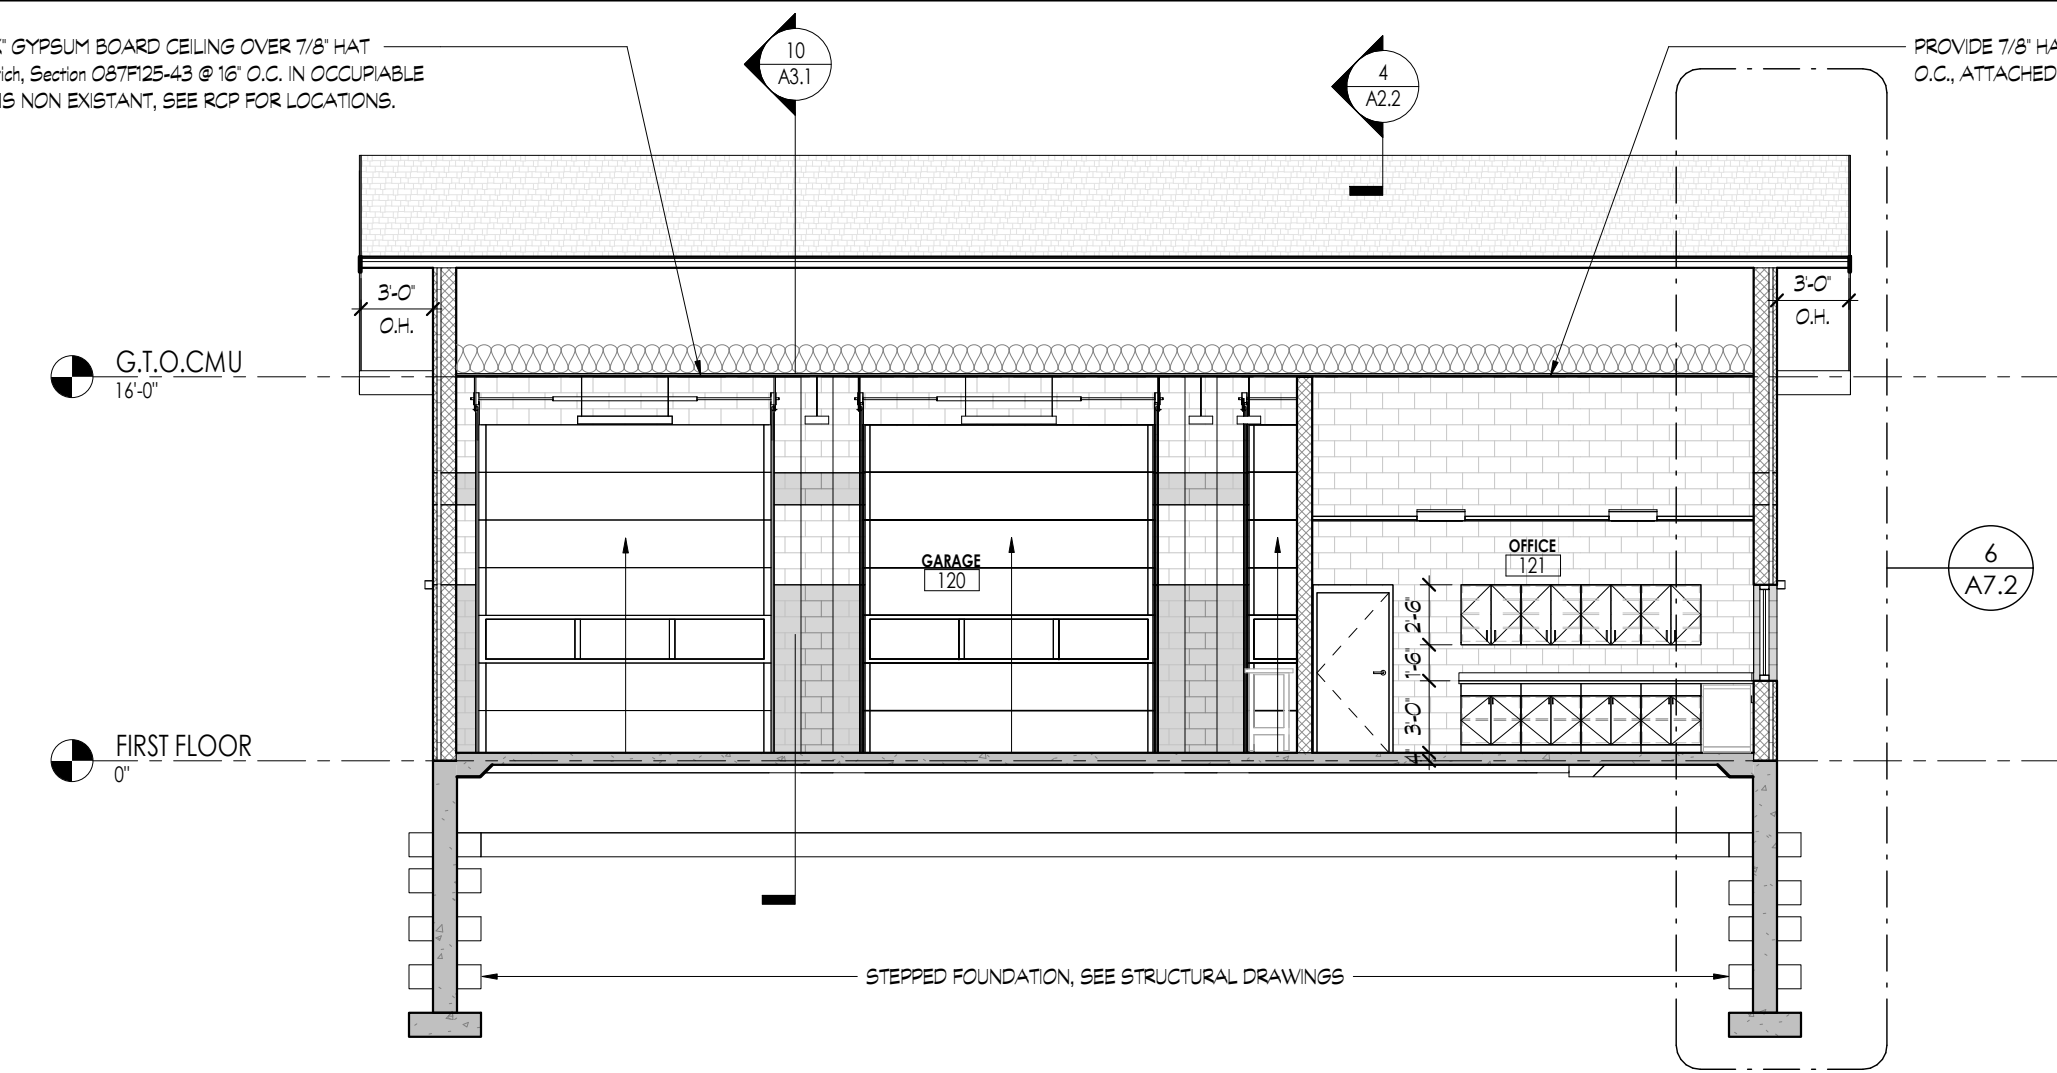

11) GARAGE BUILDING SECTION B
1/8" = 1'-0"

FIELD HOUSE LAYOUT

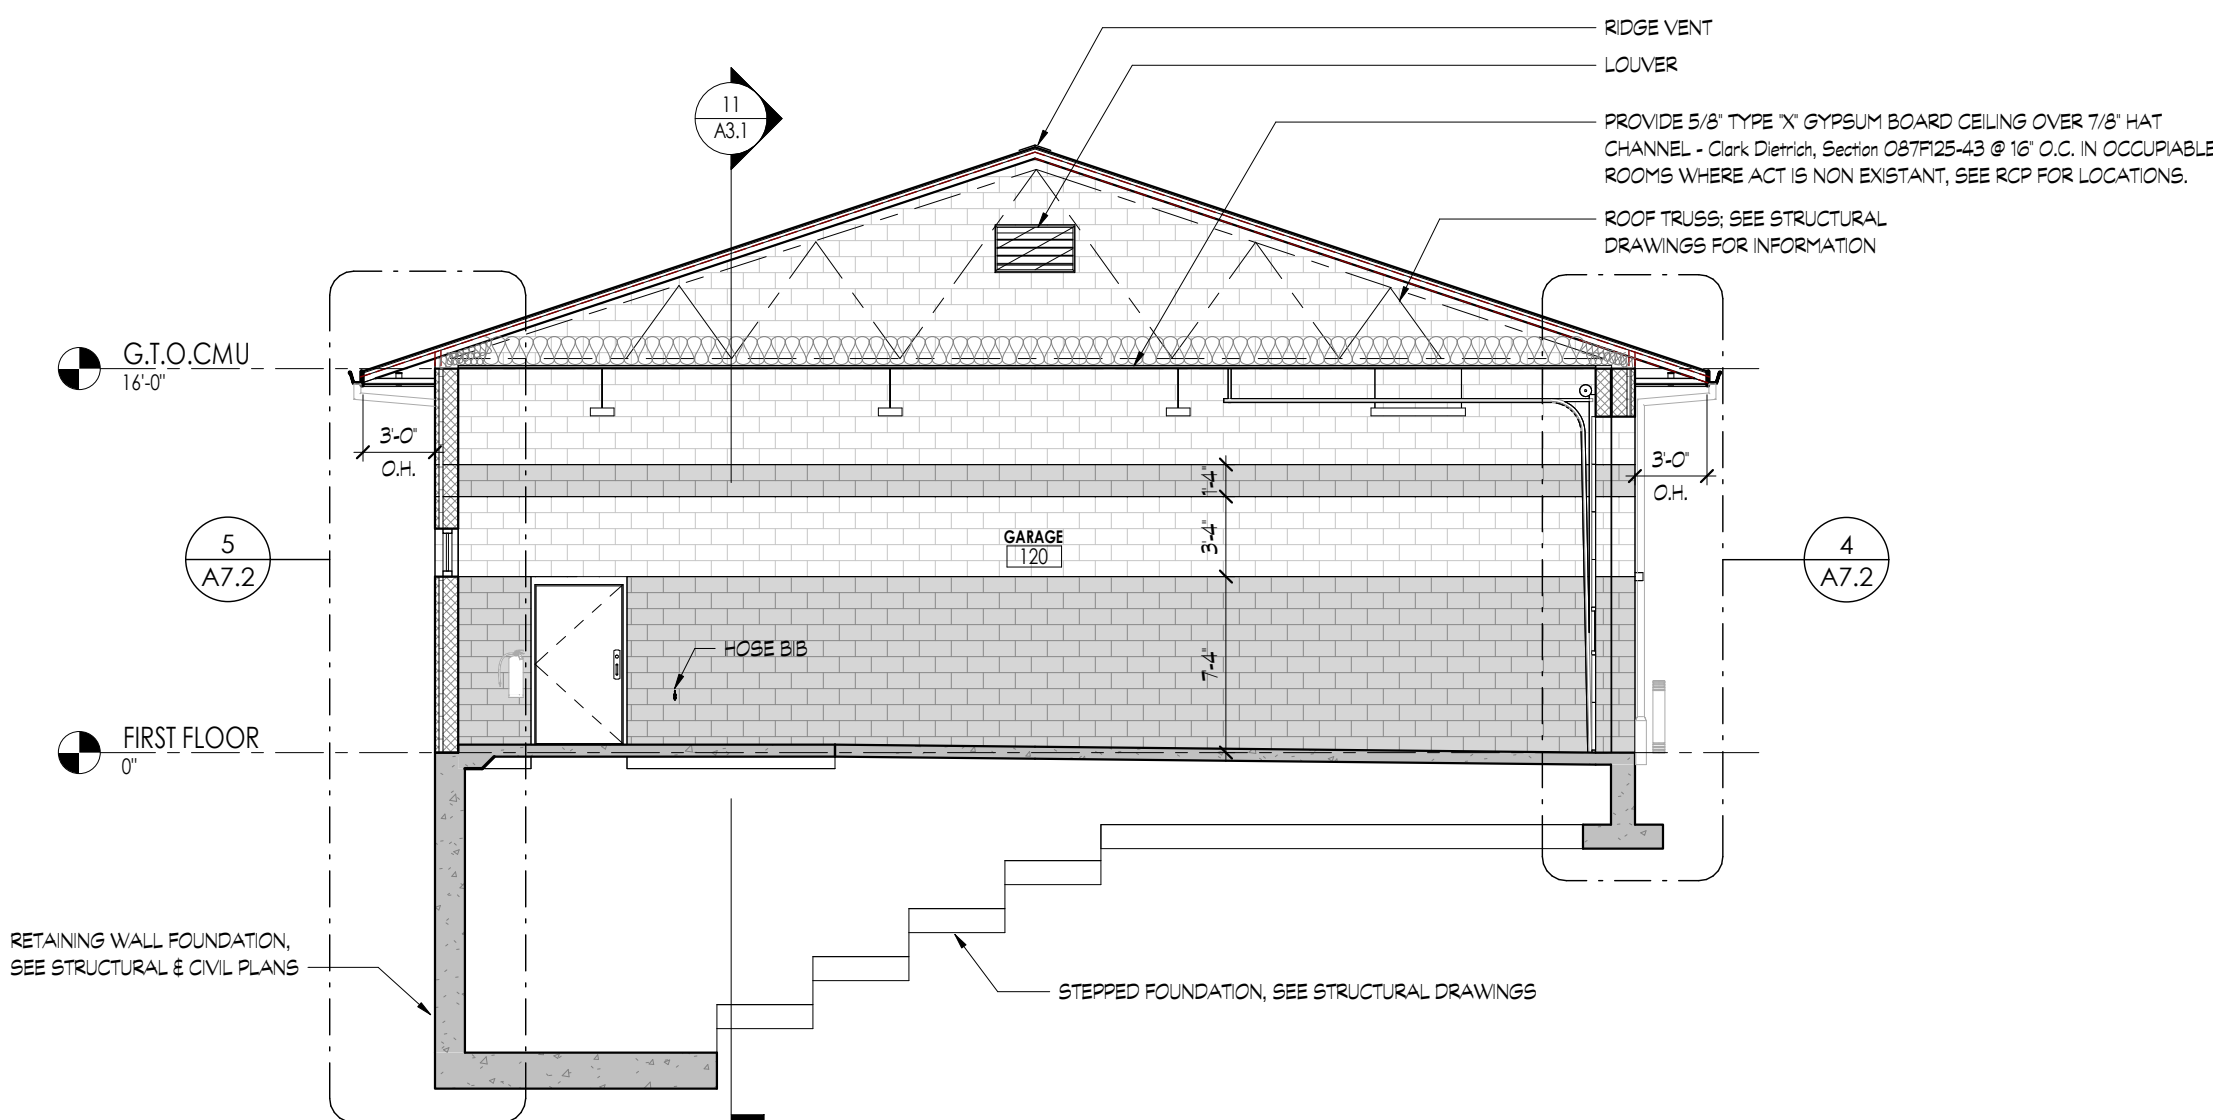


10) GARAGE BUILDING SECTION A
1/8" = 1'-0"


LIGHTING FIXTURE SCHEDULE				
MARK	MANUFACTURER	MODEL	SPECIFICATION DESCRIPTION	COMMENTS
A	KURTZON	VLX	VL-R-7-22-LED-R35-UNV-1-S	
B	SOLAR A/S	LUX-IK10	LUX-IK10-E1-S-HO3-840-4-U10-CP4-5/10-BOT-CLD-STND-H10-18Y-APH	
B1	MERCURY	LW4	LW4-4-3600-35K-H1A-18-UNIS-R	
C1	ORACLE LIGHTING	22-OT-LED-5000L	22-OT-LED-5000L-DIM10-MVOLT-35K-85-A12/INV-USA	
C2	ORACLE LIGHTING	22-OT-LED-3400L	22-OT-LED-3400L-DIM10-MVOLT-35K-85-A12/INV-USA	
C3	ORACLE LIGHTING	22-OT-LED-2400L	22-OT-LED-2400L-DIM10-MVOLT-40K-85	
D	KIRLIN	LRR-06020-1500L	LRR-06020-1500L-VOLT-35K-25	
D1	ELITE	ER3-SHAL-LED-IC	ER3-SHAL-LED-IC-900L-DIM10-MVOLT-WD-30K-90/ER3-F-1-328-SH2	
E1	REBELLE	3103	3013-214-SL-35-120-FL-FL-SC-AN	
F	MERCURY	LW4	LW4-2-2500-35K-H1A-13-UNI	
G1	EVENLITE	TELEIS	TLP-R-2U-W	

CEILING LEGEND


ACT	CEILING TYPE
ACT-1	CEILING HEIGHT
ACT-1	ACoustical CEILING TILE, MOISTURE-RESISTANT
ACT-2	ACoustical CEILING TILE, MOISTURE-RESISTANT, CLEANABLE SURFACE
RCP	FIBER CEMENT PANEL
EXP	EXPOSED CEILING
ENT	ENTRANCE
2X2	2X2 ACoustical CEILING PANEL
FIBER CEMENT PANEL	FIBER CEMENT PANEL (EXTERIOR SOFFITS ONLY)
5/8" BD.	5/8" TYPE X GYPSUM BOARD CEILING OVER 7/8" HAT CHANNEL - Clark Dennis, Section 087P25-43 @ 16" O.C. ATTACHED TO UNDERSIDE OF TRUSS BOTTOM CHORD.

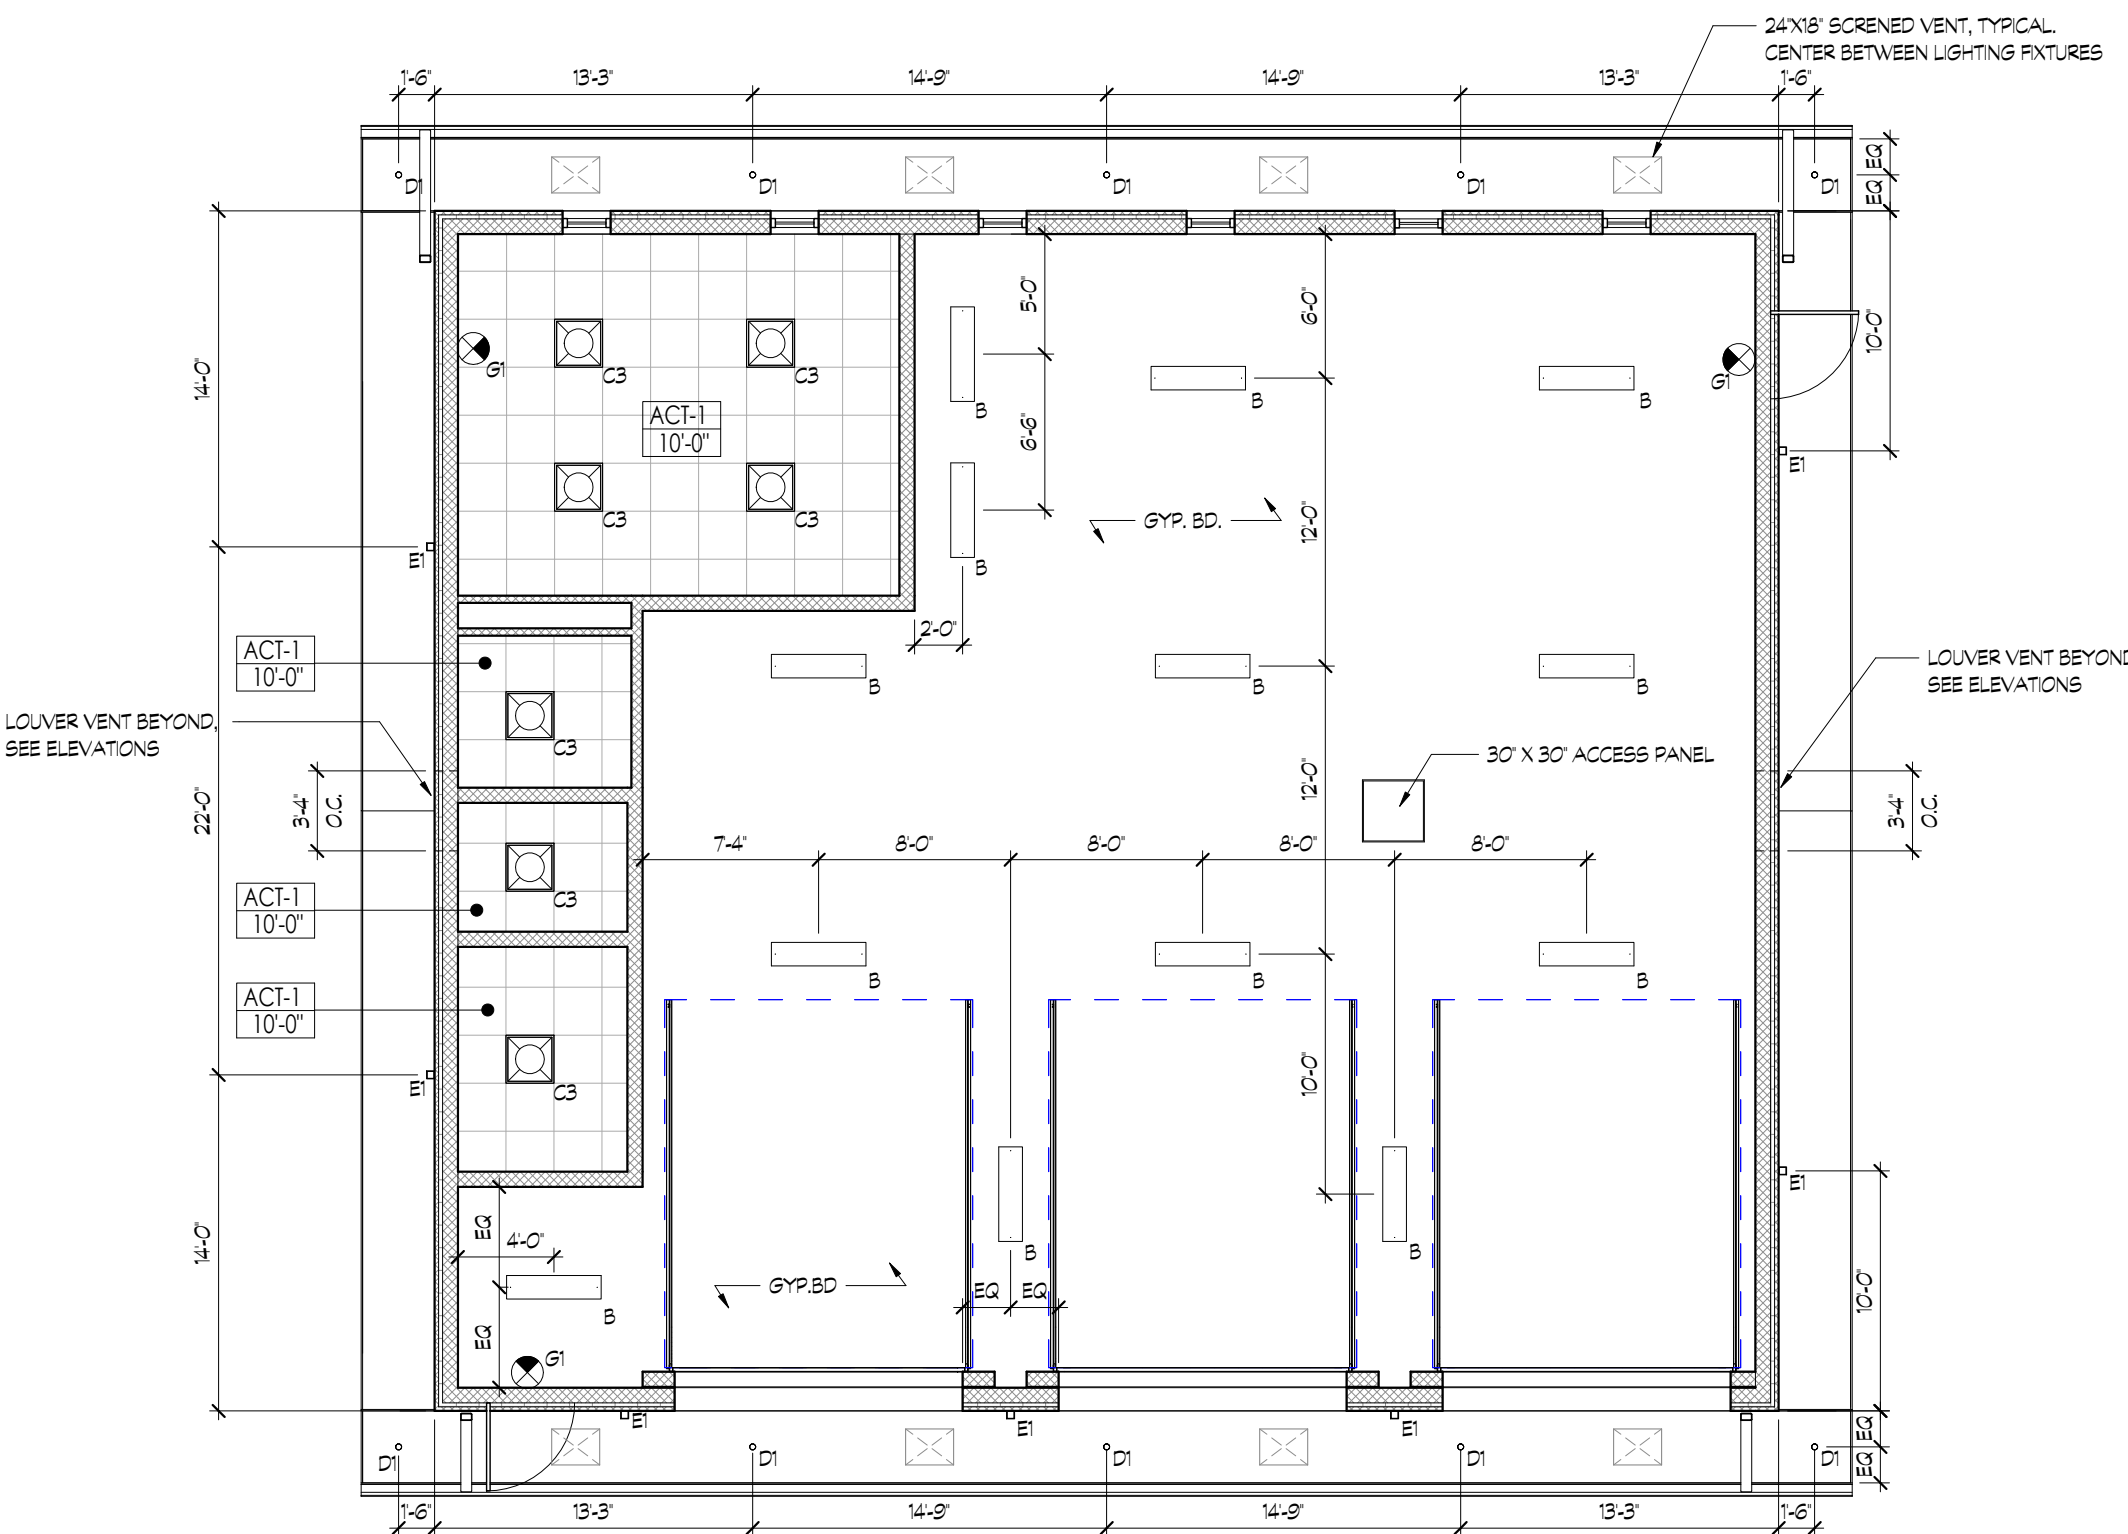


2) GARAGE BUILDING - FIRST FLOOR RCP
1/8" = 1'-0"

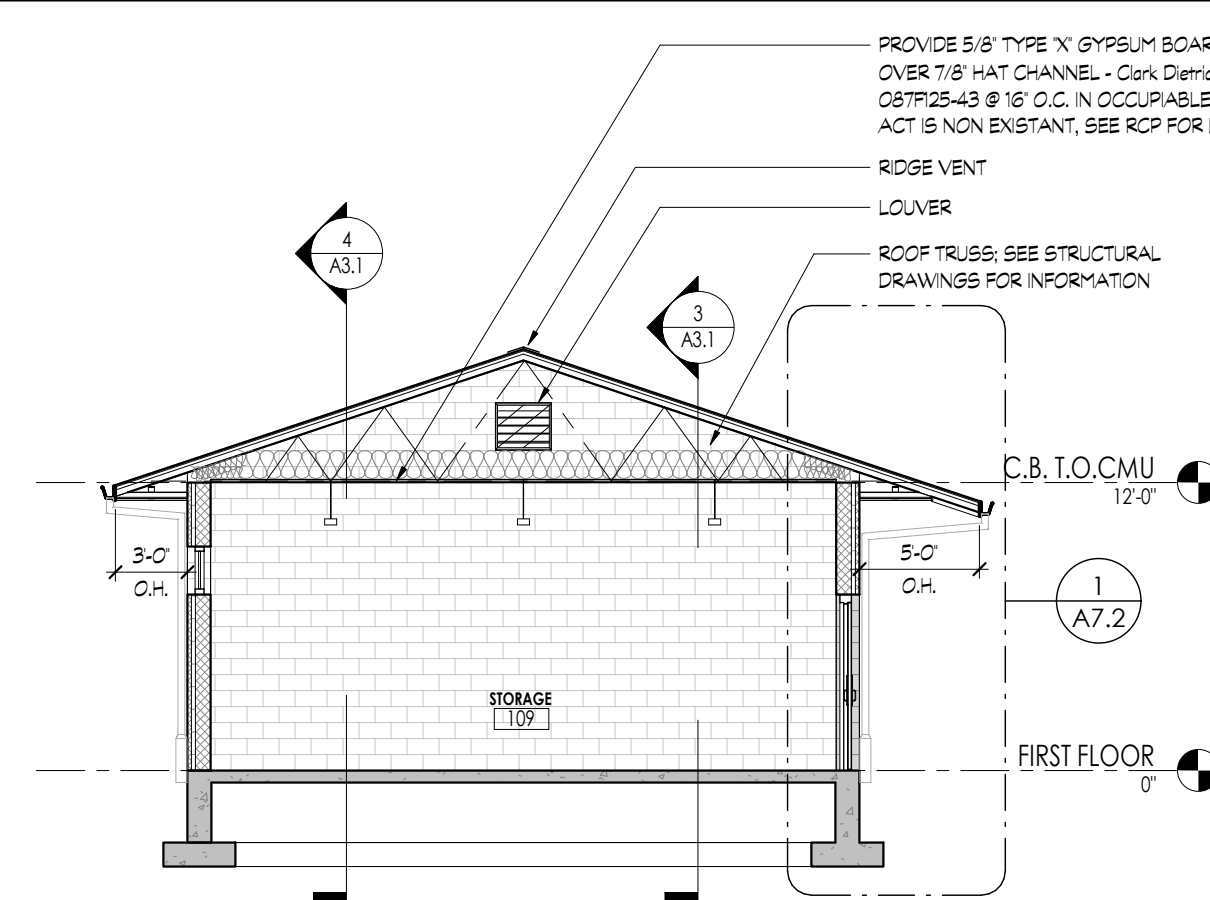


9) FIELD HOUSE BUILDING - TRANSVERSE SECTION E
1/8" = 1'-0"

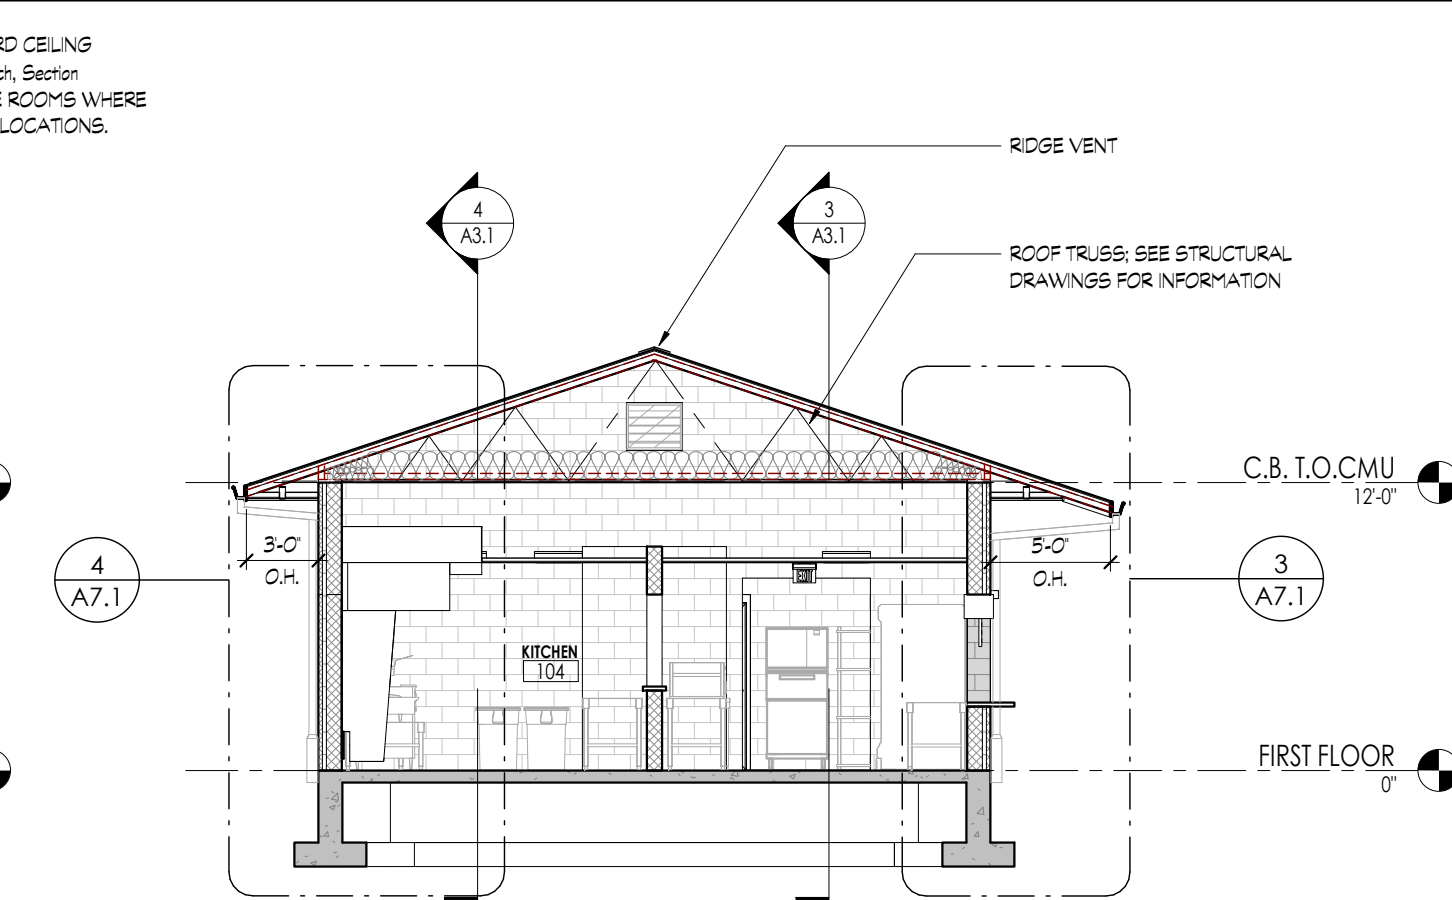


7) FIELD HOUSE BUILDING - TRANSVERSE SECTION C
1/8" = 1'-0"

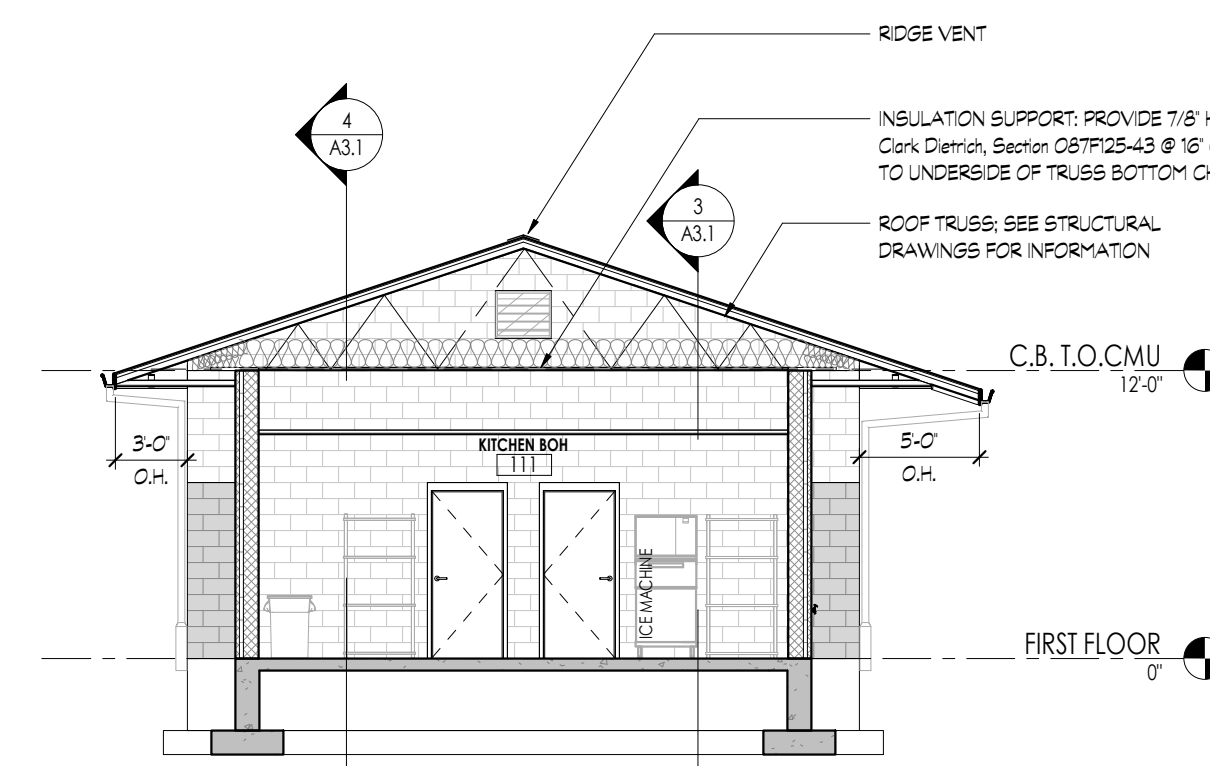


8) FIELD HOUSE BUILDING - TRANSVERSE SECTION D
1/8" = 1'-0"

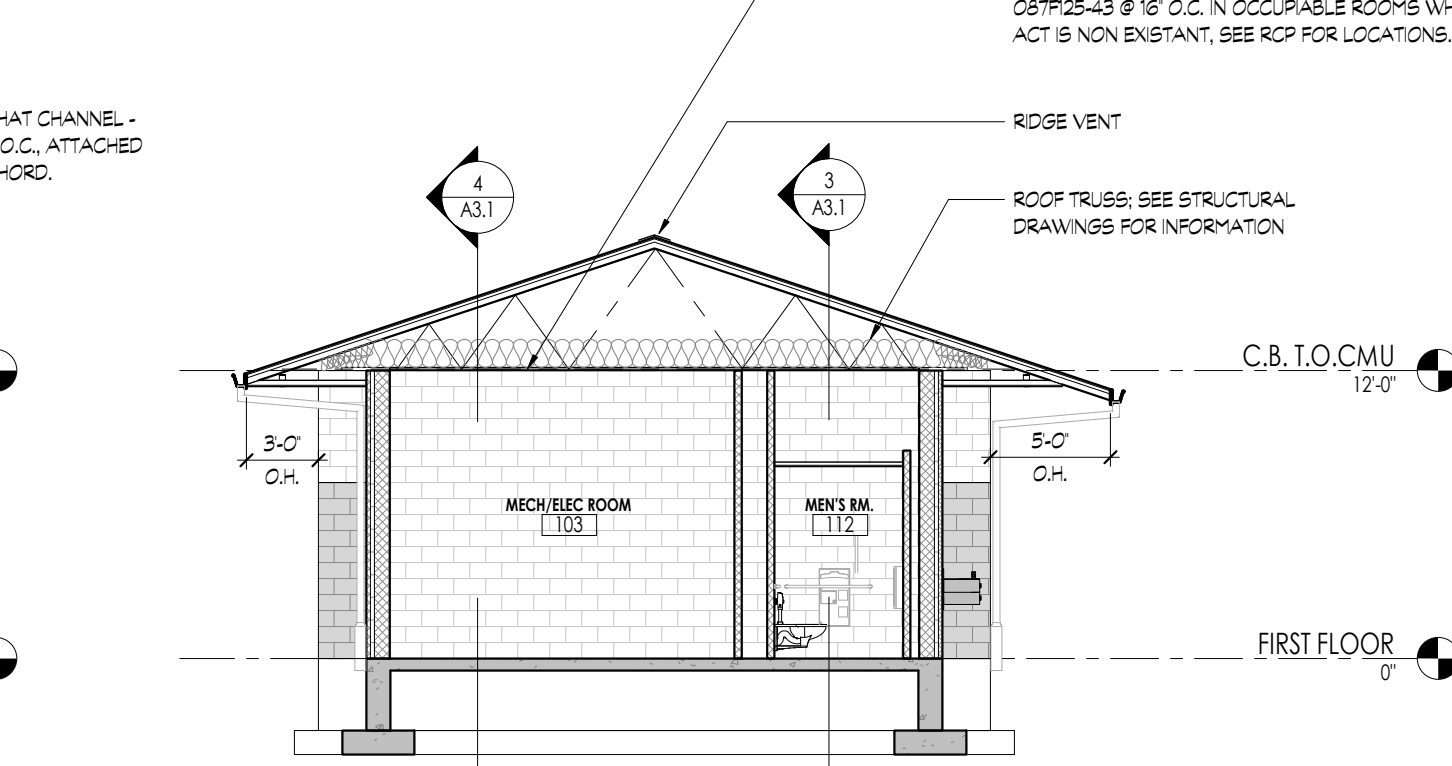


6) FIELD HOUSE BUILDING - TRANSVERSE SECTION B
1/8" = 1'-0"

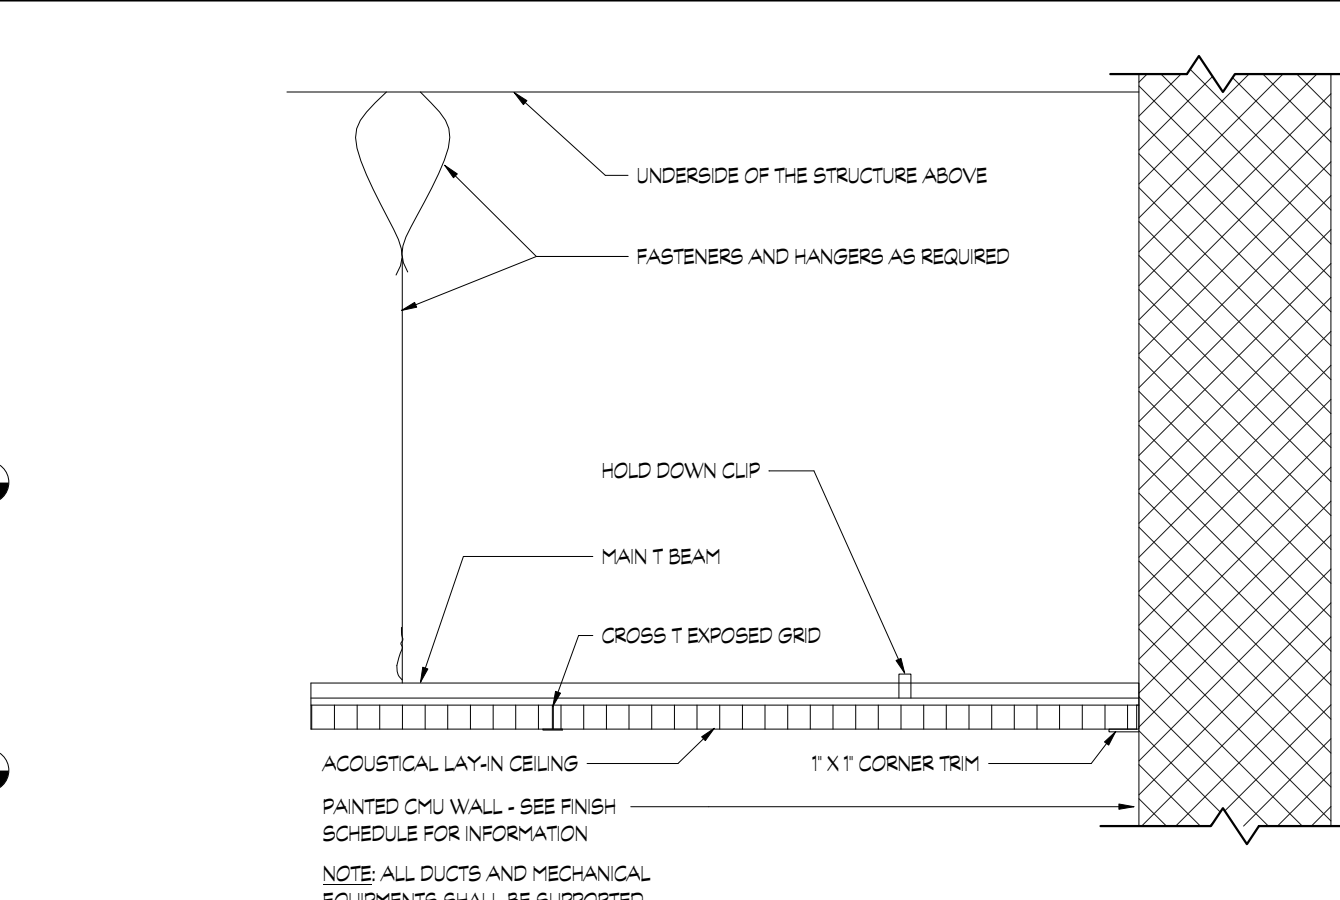


5) FIELD HOUSE BUILDING - TRANSVERSE SECTION A
1/8" = 1'-0"

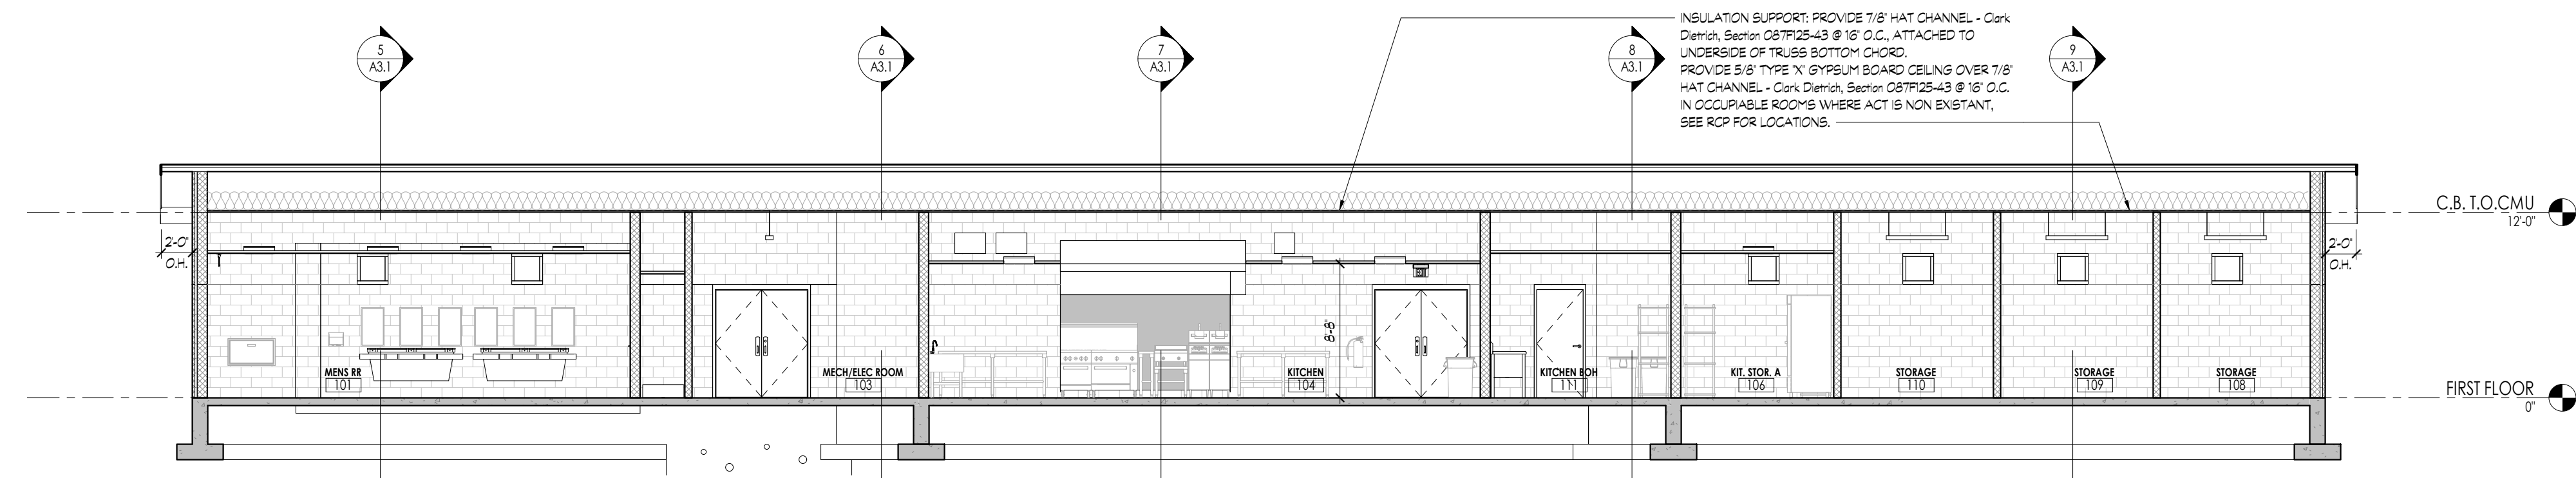

4) FIELD HOUSE BUILDING - LONGITUDINAL SECTION B
1/8" = 1'-0"

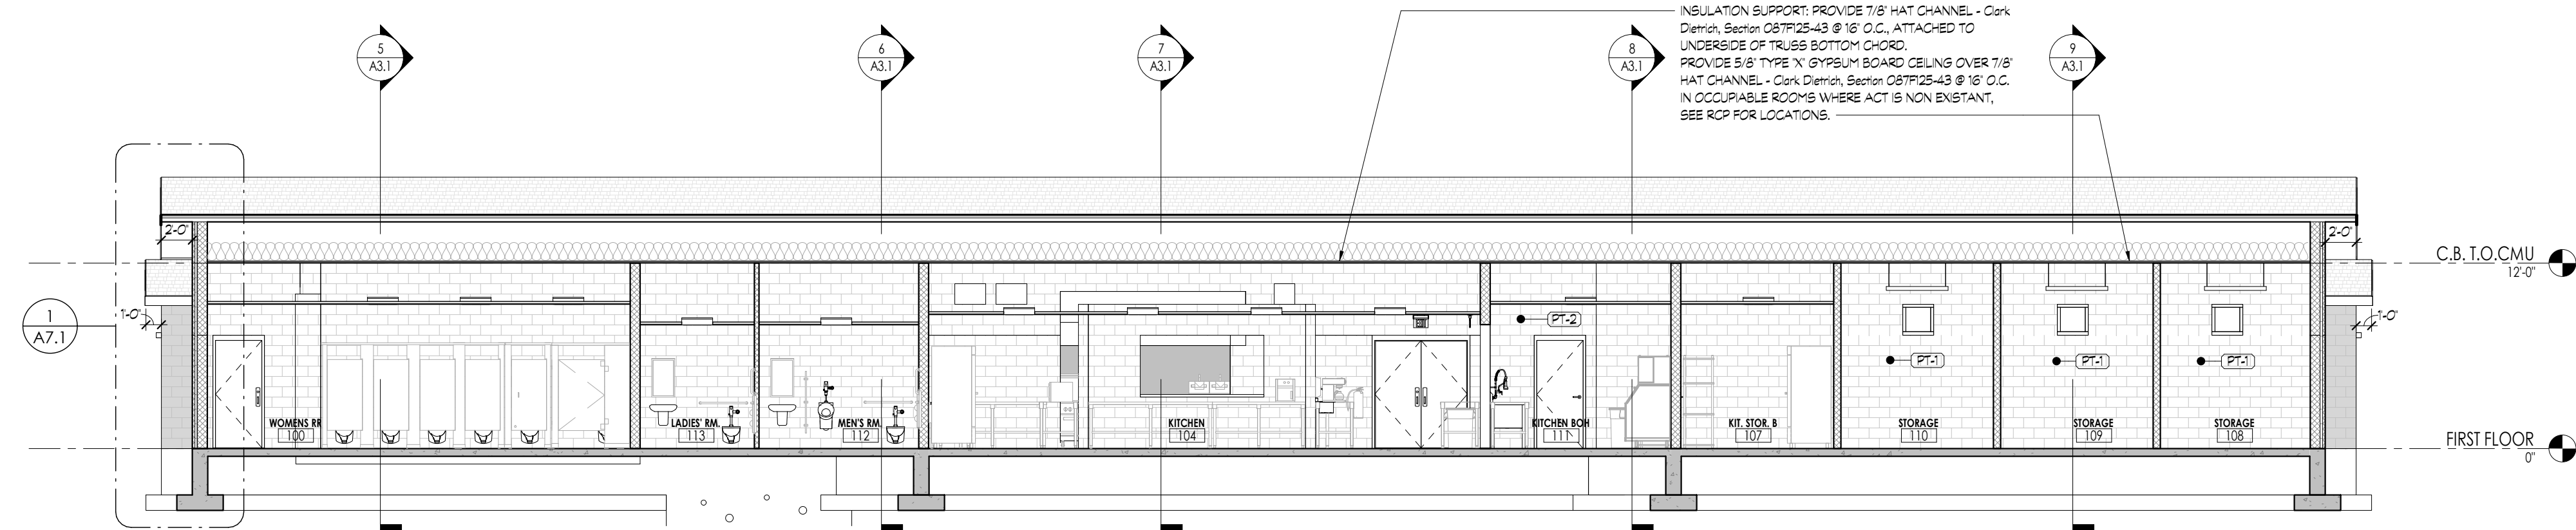

3) FIELD HOUSE BUILDING - LONGITUDINAL SECTION A
1/8" = 1'-0"

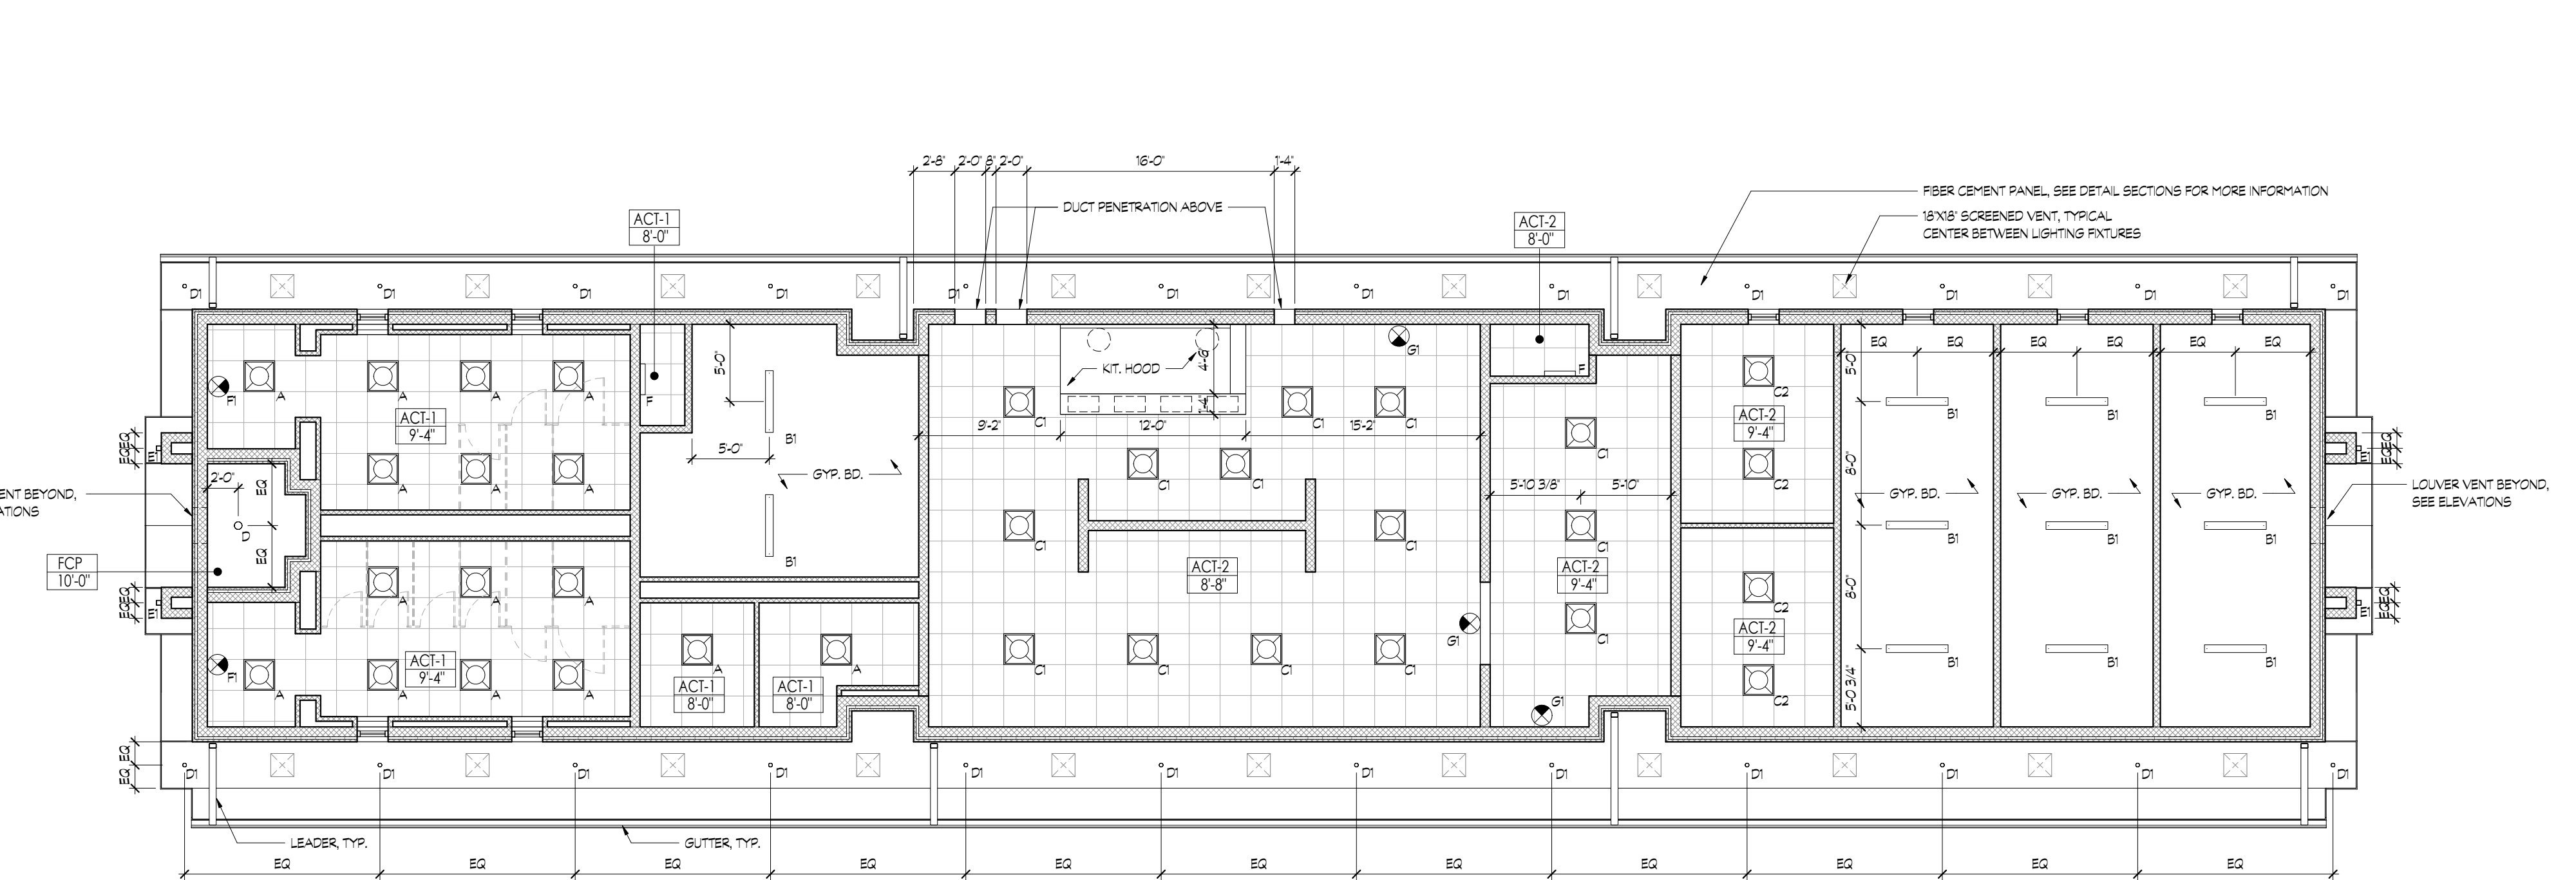

1) FIELD HOUSE BUILDING - FIRST FLOOR RCP
1/8" = 1'-0"

Key Plan

PHASE 1

RECREATION BUILDING

CONSTRUCTION

PHASE 1

PROJECT NORTH

TRUE NORTH

PROJECT

WOOD-RIDGE RECREATION COMPLEX

30 Kennedy Lane
Block 320, Lot 1.02
Borough of Wood-Ridge
Bergen County, NJ 07075

CIVIL ENGINEER:

NEGLIA

ENGINEERING ASSOCIATES

34 Park Avenue - P.O. Box 426
Lyndhurst, New Jersey 07037
200 Central Avenue - Suite 102
Mountaindale, NJ 07092
(201) 978-6800

STRUCTURAL ENGINEER:

McLaren

ENGINEERING GROUP

530 Chestnut Ridge Road
Woodcliff Lake, NJ 07677
(201) 775-6000

M/E/P/FP ENGINEER:

KeRi

ENGINEERING PC

911 Springfield Road, Suite 2
Union, NJ 07080
973-866-5374

DMR

ARCHITECTURE
PLANNING
ENGINEERING
INTERIORS
CONSULTING

www.dmrarchitects.com

MEMBERS OF THE AMERICAN INSTITUTE OF ARCHITECTS

LLOYD A. ROSENBERG NJ - C 6526
CRESC STORP NJ - AI 09413
KURT A. WIERHELIC NJ - AI 17809

NOT VALID FOR BUILDING PERMITS AND SEALS BY ARCHITECT

777 Terrace Avenue, 6th Floor
Hoboken Heights, New Jersey 07030
16-201-288-2400, Fax 201-288-2402

NCARB NATIONAL COUNCIL OF ARCHITECTURAL REGISTRATION BOARDS
CO-306 184 CT-05438 NJ-AI 03326
NJ BOARD OF PROFESSIONAL PLANNERS I-011584
NY-013025-1 PA-RA 13437-B

TITLE
P1 - FIELDHOUSE &
GARAGE REFLECTED
CEILING PLANS & BUILDING
SECTIONS

SCALE As indicated

DATE	DESCRIPTION	DRN	CHK
06-19-2020	ISSUED FOR CLIENT REVIEW	-	-
07-10-2020	ISSUED FOR CONSTRUCTION	-	-

REV.	DATE	DESCRIPTION	BY:	TO:

PROJECT NO.	SHEET NO.
4360	A3.1

Copyright © 2020 by DMR

PLOT DATE: 7/14/2020 12:59:26 PM

